


ALL WORKS TO NCC CURRENT

ITEM	QTY.	DESCRIPTION	REMARKS
SCALES	as shown	TITLE	PROPOSED RFS EUGOWRA STATION
DRAWN	GKT	DATE	03-10-23
CHECKED	APRVD		
CLIENT	CORE RURAL CONSULTING	FILE NAME	RFS-101
		SHEET	02 OF 04 SHEETS

REV.	DATE	AMENDMENT	DRAWN	CHECKED
B	28-2-24	FOR REVIEW-CHANGES AS REQUESTED	GKT	CRC
A	03-10-23	FOR REVIEW	GKT	CRC



DRG. No. **KD-RFS-101** REV. **B**

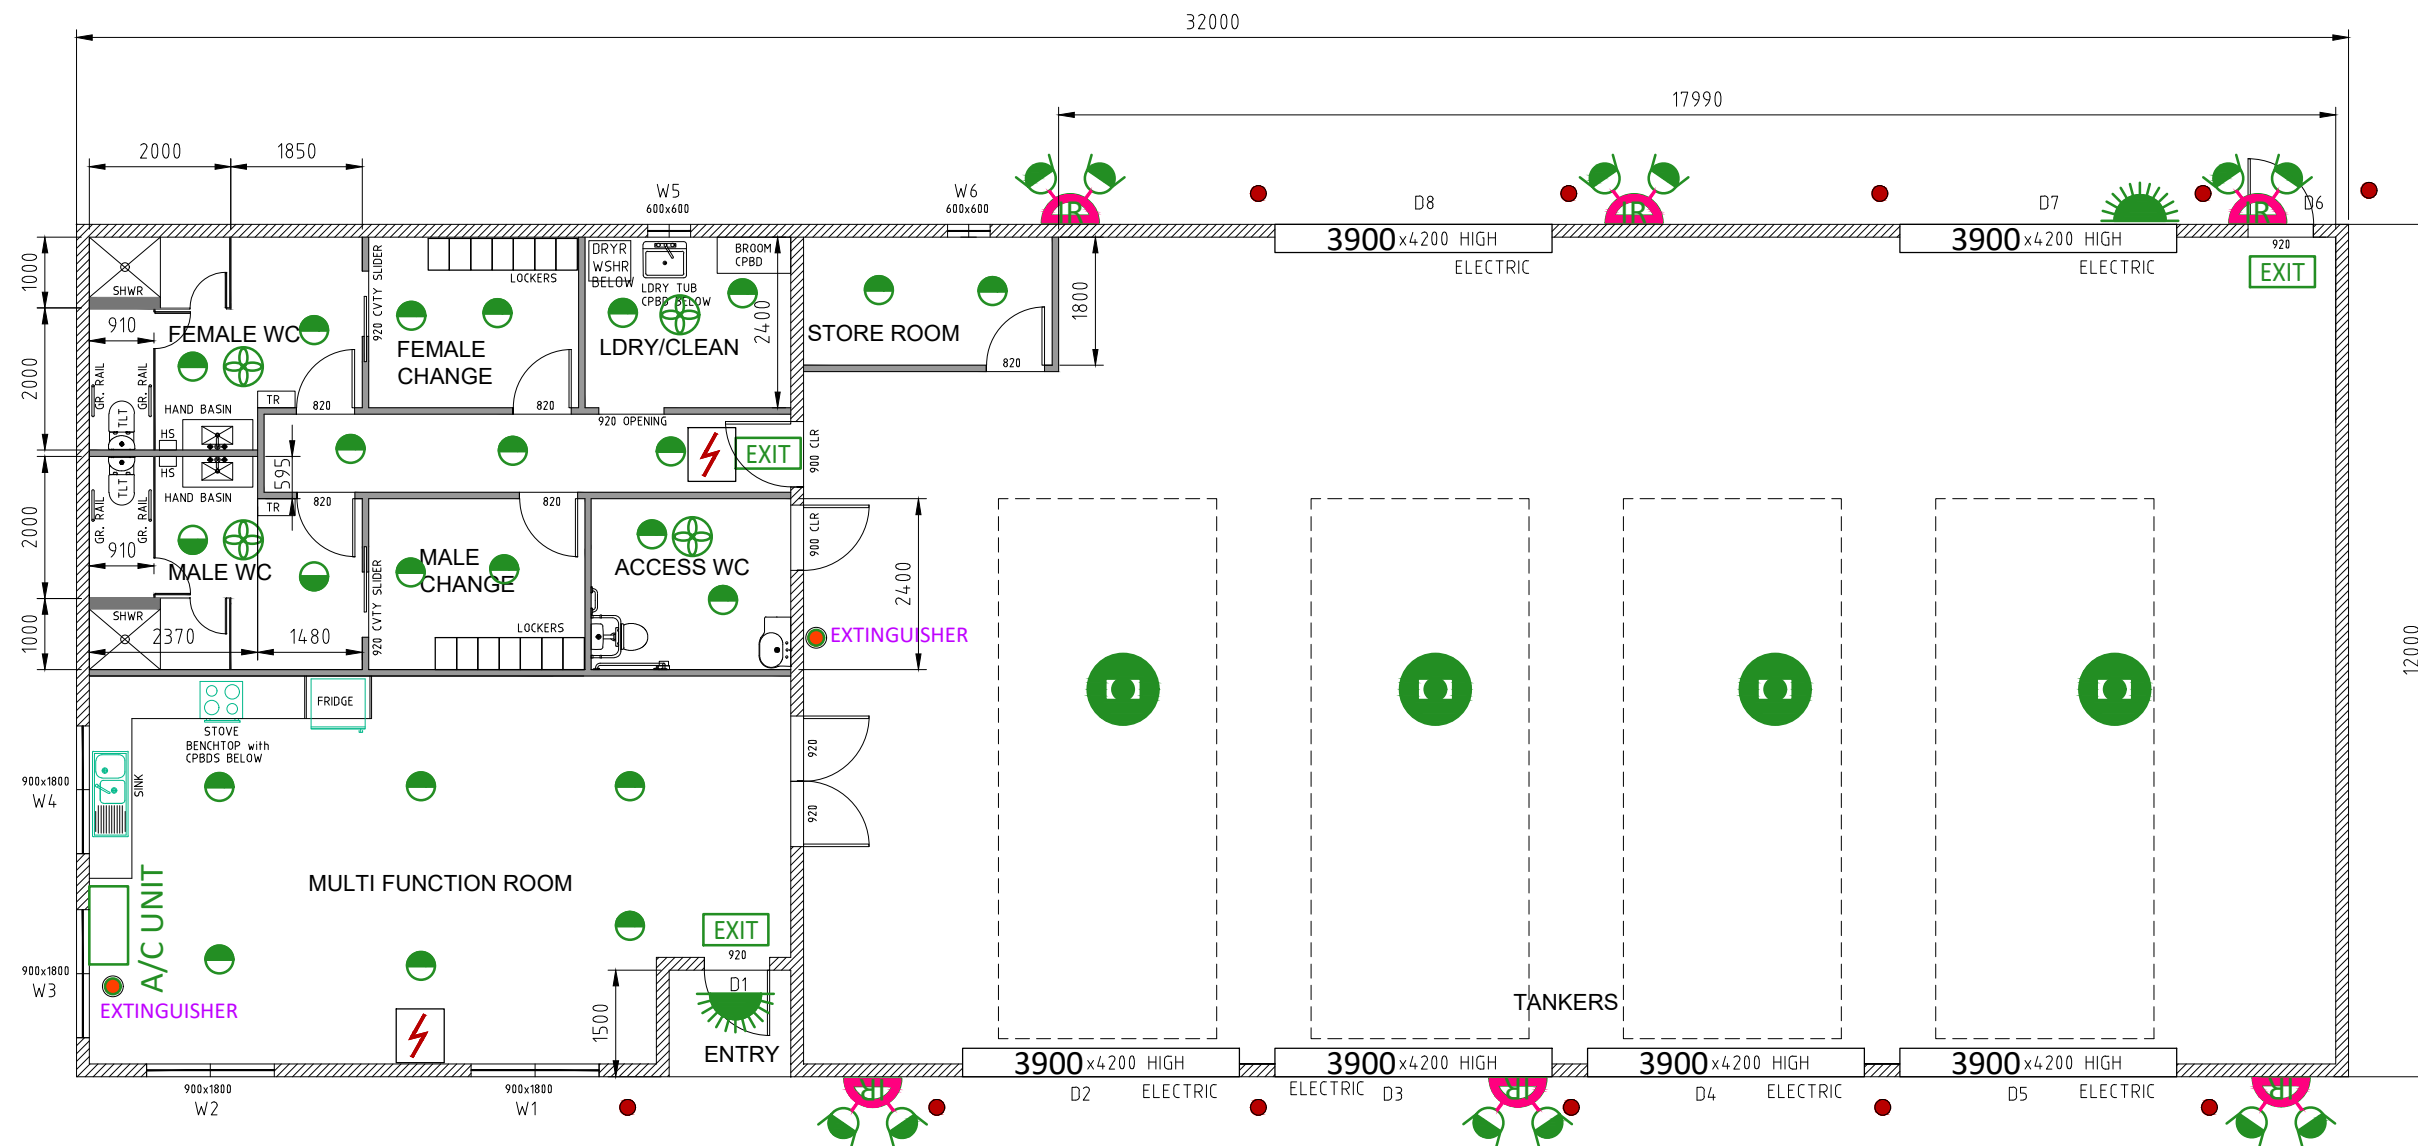


Emergency lighting complying with AS/NZS2293.1 being provided throughout the building in accordance with Clause E4.2


- HIGH BAY LIGHT
- LED DOWNLIGHT
- SENSOR LIGHT
- SENSOR DOUBLE LED LIGHT
- SMOKE DETECTOR
- EMERGENCY EXIT SIGN

REV.	DATE	AMENDMENT	DRAWN	CHECKED
B	28-2-24	FOR REVIEW-CHANGES AS REQUESTED	GKT	CRC
A	03-10-23	FOR REVIEW	GKT	CRC

ITEM	QTY.	DESCRIPTION	REMARKS
SCALES as shown		TITLE PROPOSED RFS EUGOWRA STATION	
DRAWN GKT		DATE 03-10-23	4 TANKER LIGHTING PLAN
CHECKED		APRVD	
CLIENT CORE RURAL CONSULTING		FILE NAME RFS-101	SHEET 02 OF 04 SHEETS
KENNETH DRAFTING			DRG. No.
			KD-RFS-101
			REV. B

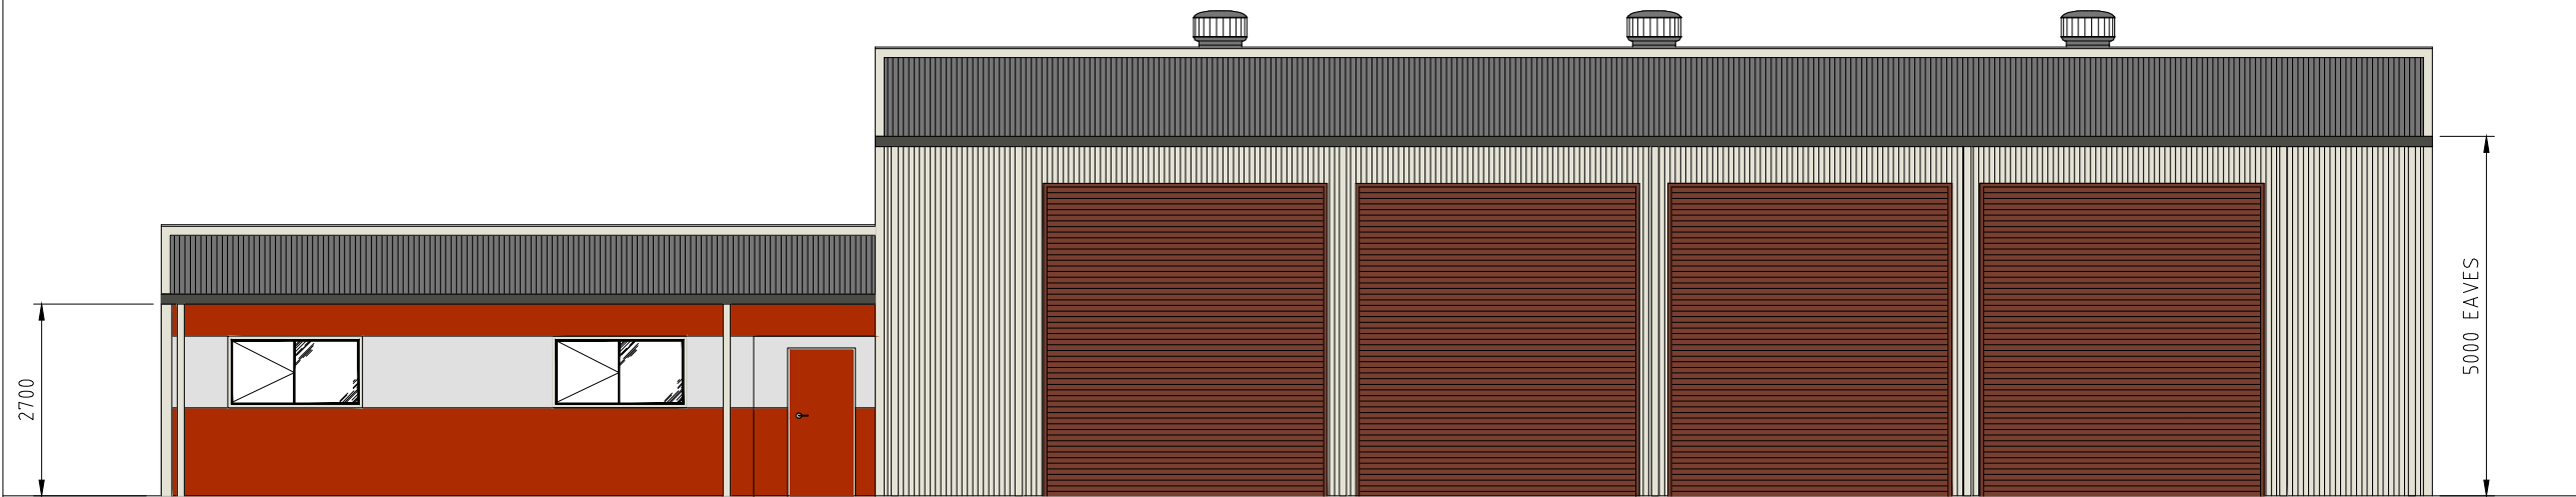

FRONT ELEVATION
SCALE 1:100

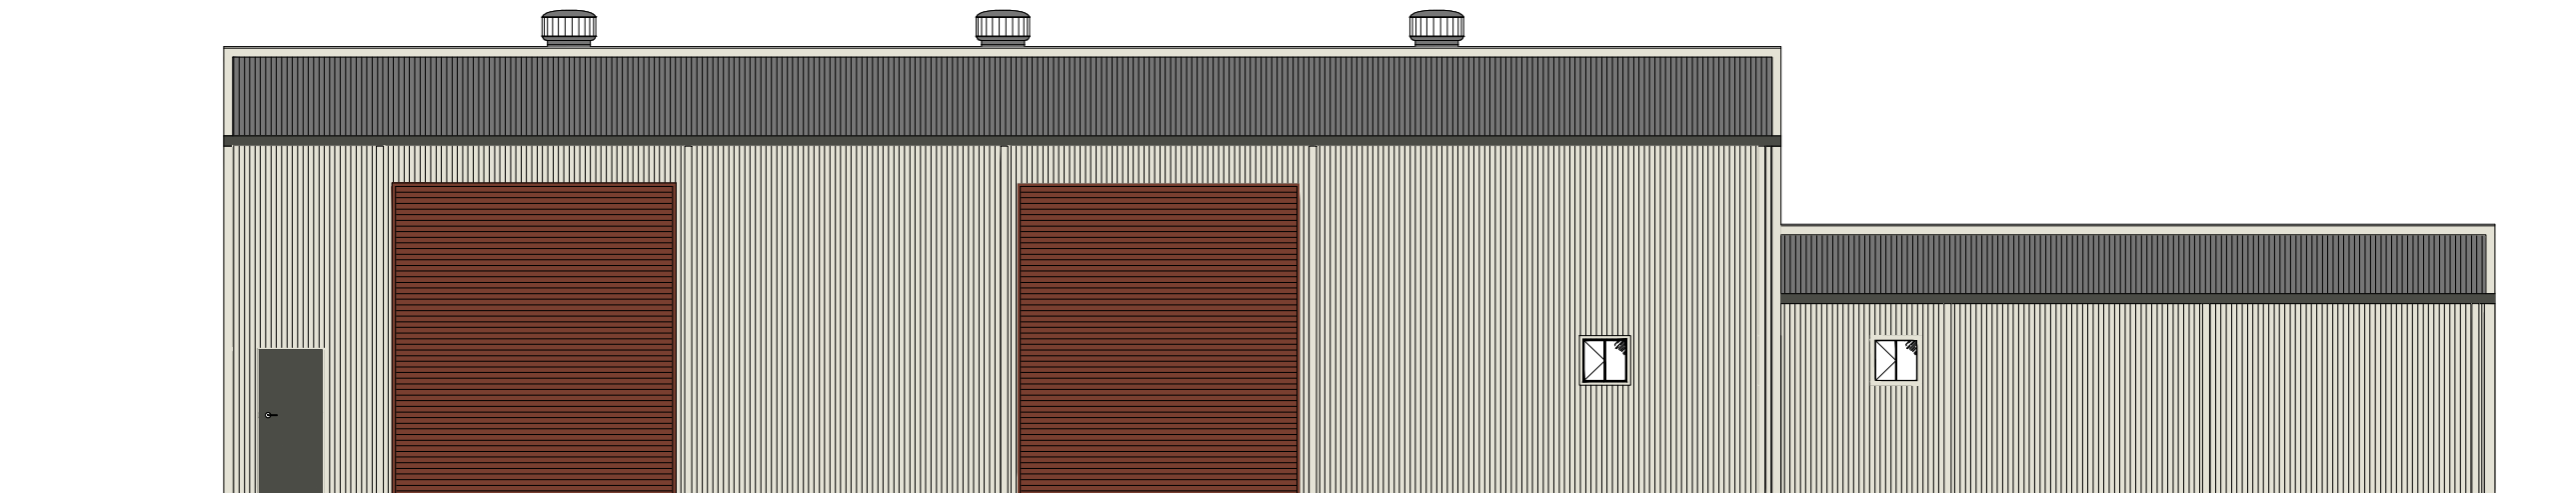


REAR ELEVATION
SCALE 1:100


ITEM	QTY.	DESCRIPTION		REMARKS
SCALES		as shown		TITLE PROPOSED RFS EUGOWRA STATION 4 TANKER ELEVATIONS SHEET 1 OF 2
DRAWN		GKT	DATE 03-10-23	
CHECKED		APRVD		
CLIENT		CORE RURAL CONSULTING		FILE NAME RFS-101
				SHEET 03 OF 04 SHEETS
B	28-2-24	FOR REVIEW-CHANGES AS REQUESTED		GKT CRC
A	03-10-23	FOR REVIEW		GKT CRC
REV.	DATE	AMENDMENT		DRAWN CHECKED

**KENNETH
DRAFTING**

DRG. No. KD-RFS-101 REV. B

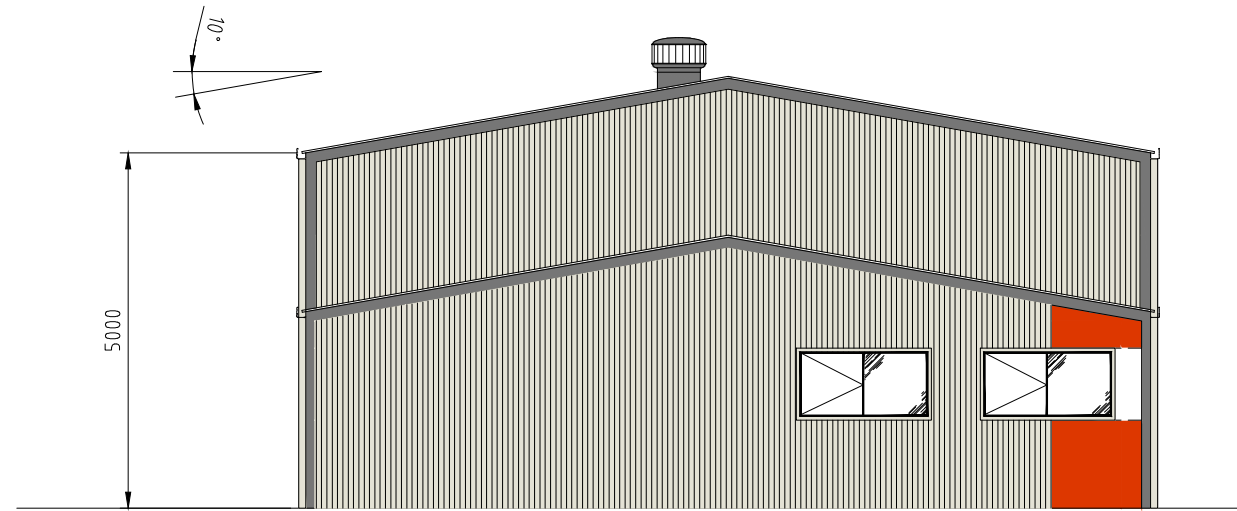

SIDE ELEVATION
SCALE 1:100

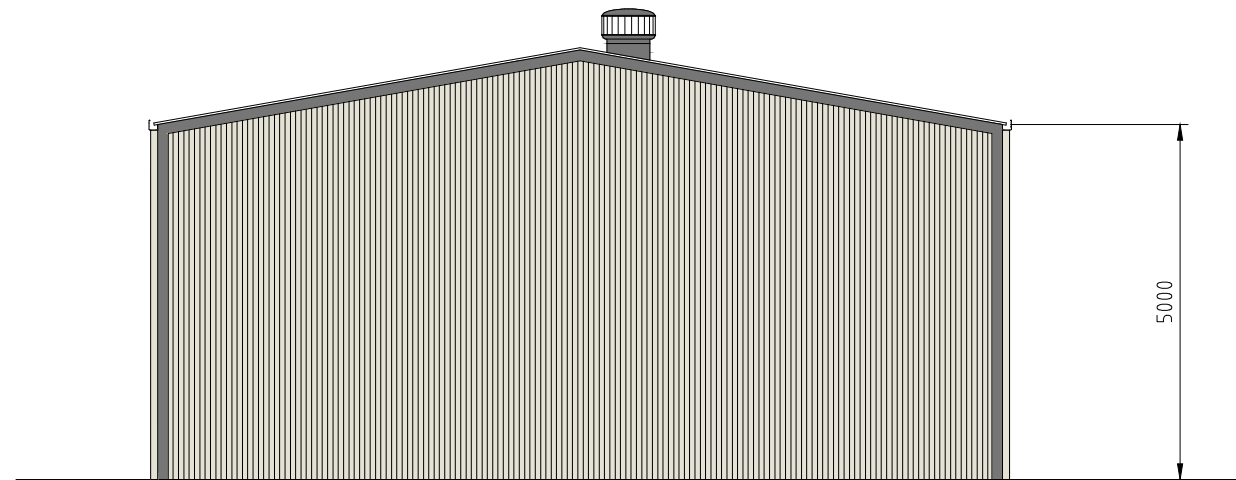

SIDE ELEVATION
SCALE 1:100

ITEM	QTY.	DESCRIPTION	REMARKS
SCALES as shown		TITLE PROPOSED RFS EUGOWRA STATION	
DRAWN GKT		DATE 3-10-23	4 TANKER
CHECKED		APRVD	ELEVATIONS SHEET 2 OF 2
CLIENT CORE RURAL CONSULTING		FILE NAME RFS-101	SHEET 04 OF 04 SHEETS
B	28-2-24	FOR REVIEW-CHANGES AS REQUESTED	GKT CRC
A	03-10-23	FOR REVIEW	GKT CRC
REV.	DATE	AMENDMENT	DRAWN CHECKED

KENNETH DRAFTING

DRG. No. KD-RFS-101 REV. B